




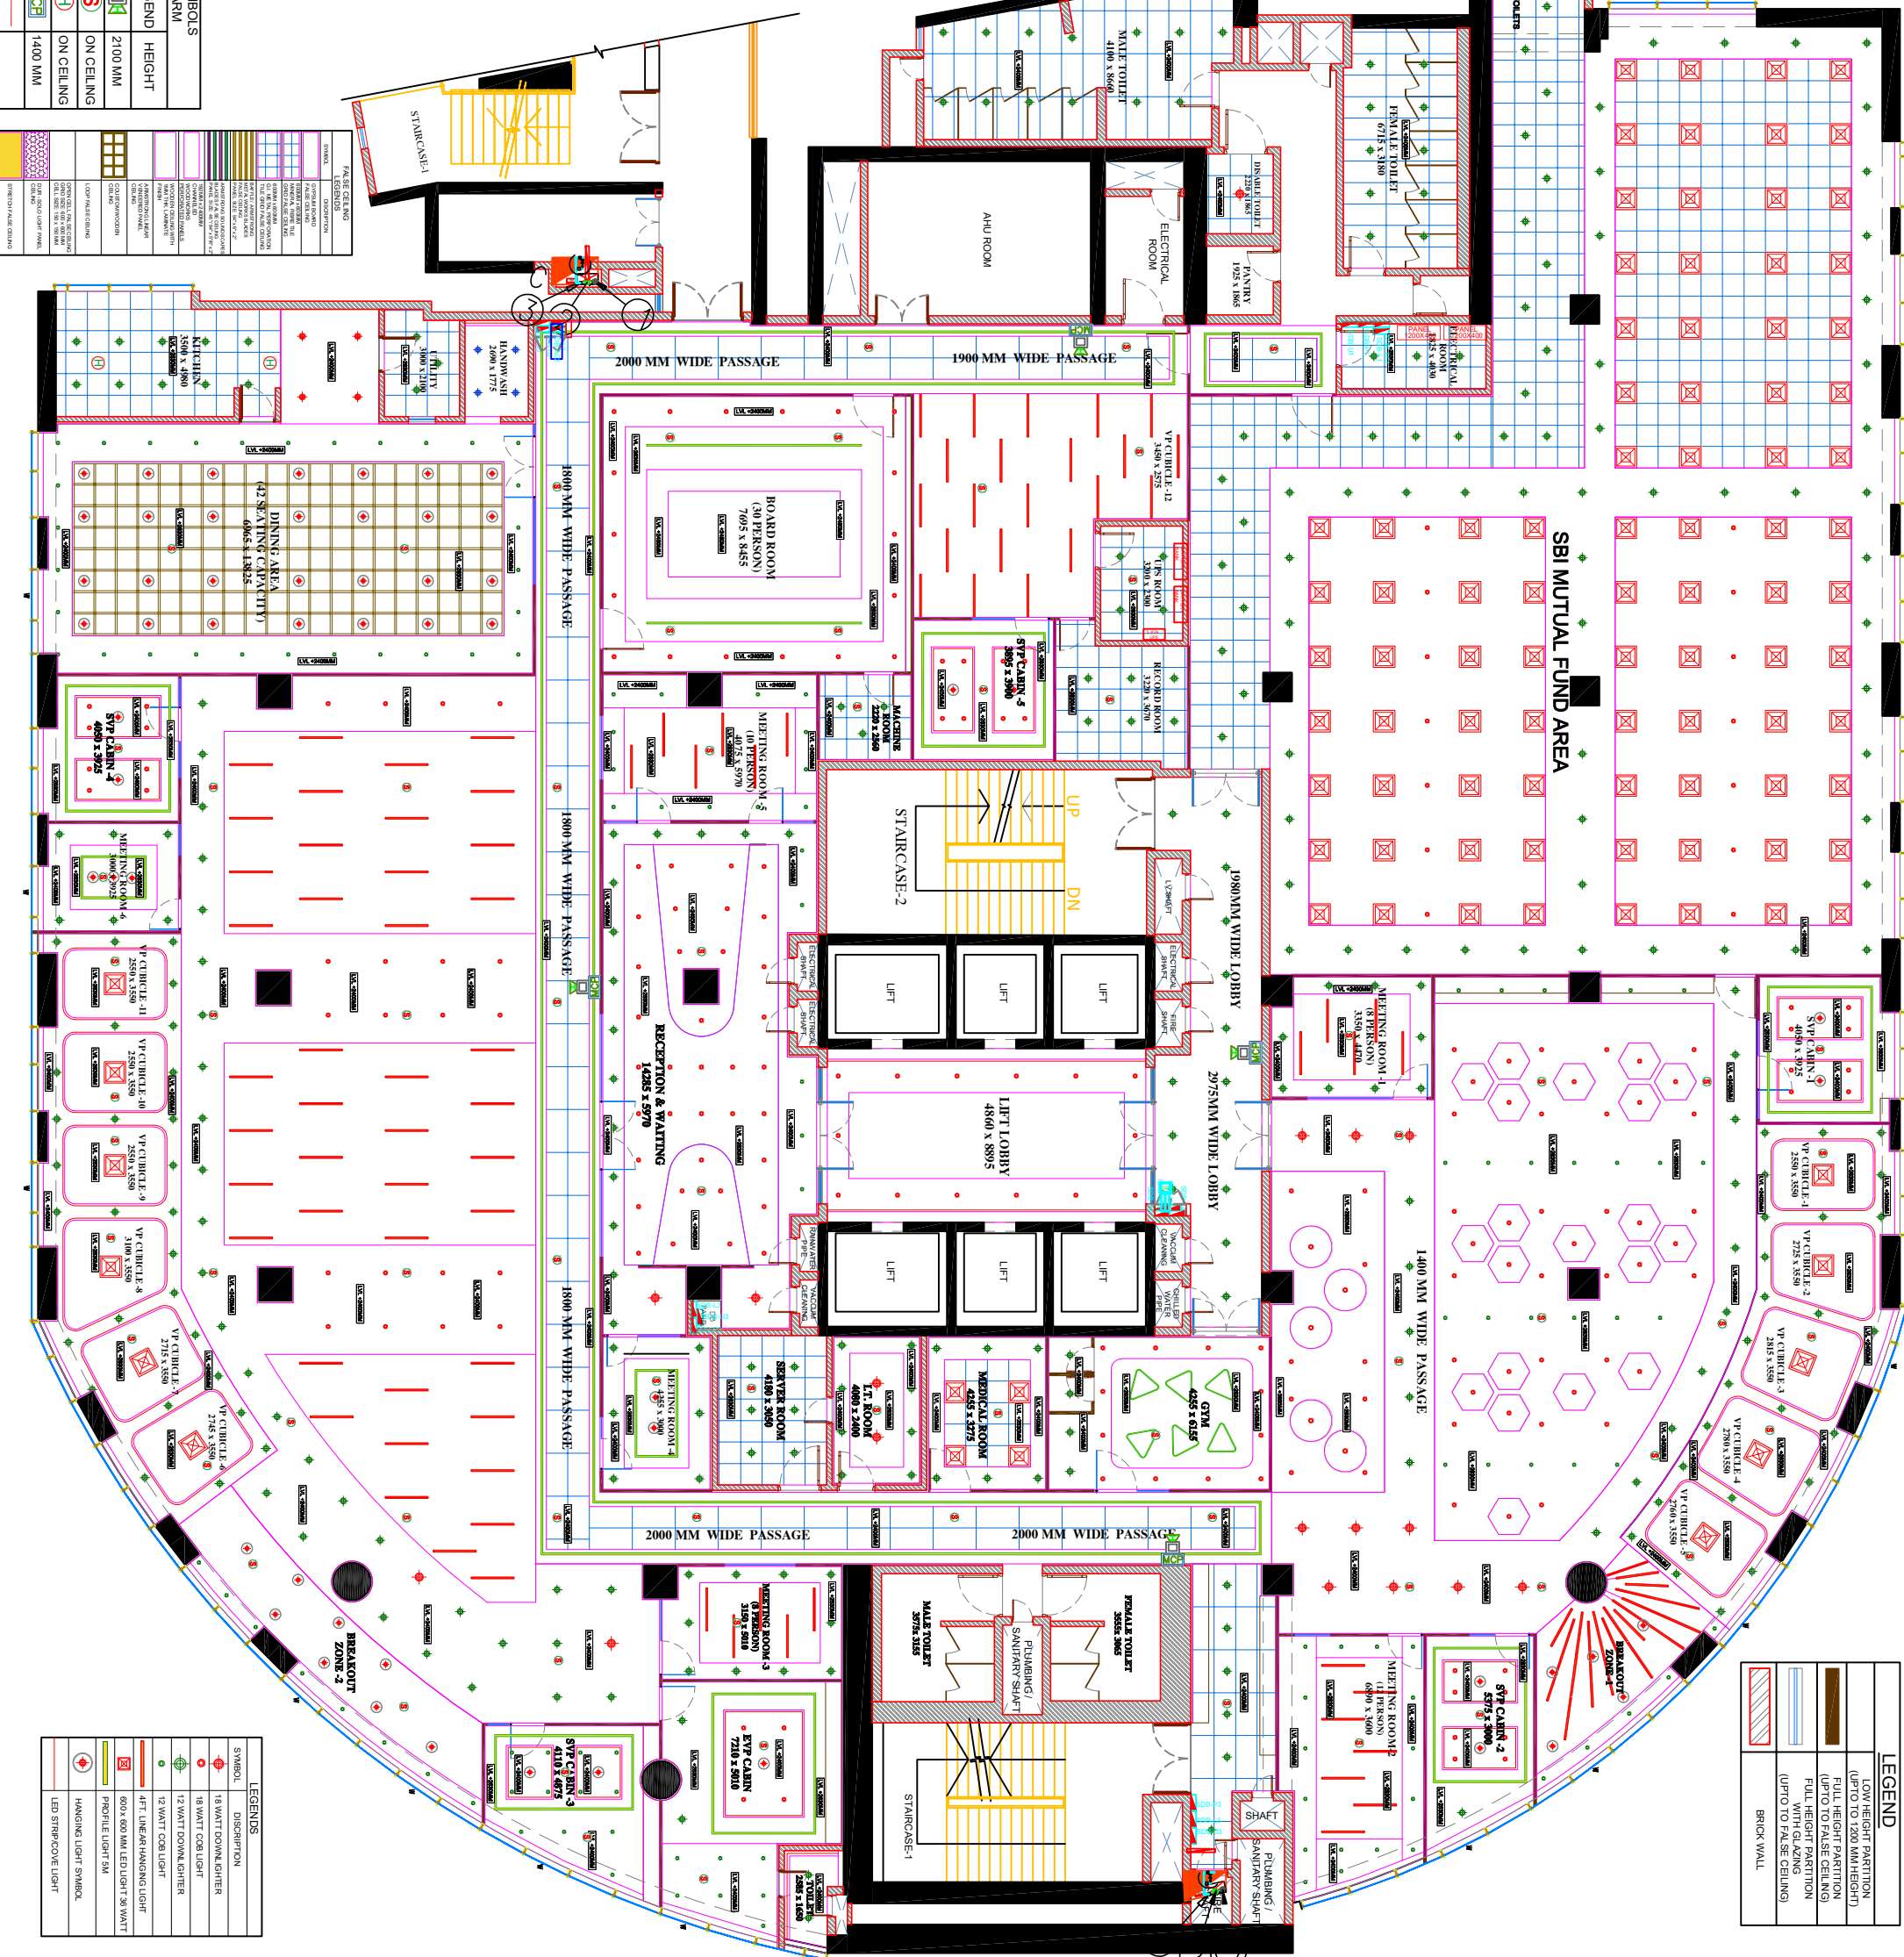


1. This drawing is a property of **THE GRID**.
2. Any modification/changes to the drawing can be done only after written permission from **THE GRID**.
3. This drawing must be read along with other architecture & services drawings.


 


LEGEND	
	LOW HEIGHT PARTITION (UPTO 1200 MM HEIGHT)
	FULL HEIGHT PARTITION (UPTO TO FALSE CEILING)
	FULL HEIGHT PARTITION WITH GLAZING
	UP TO FALSE CEILING
	BRICK WALL

DESCRIPTION OF SYMBOLS USED FOR FIRE ALARM		
S.NO	DESCRIPTION	HEIGHT
1.	HOOTER	2100 MM
2.	SMOKE DETECTOR	ON CEILING
3.	HEAT DETECTOR	ON CEILING
4.	MANUAL CALL POINT	1400 MM
5.	FIRE LOOP	

[illegible]

LEGENDS	
SYMBOL	DISRUPTION
	16 WATT DOWN LIGHTER
	18 WATT COB LIGHT
	12 WATT DOWN LIGHTER
	12 WATT COB LIGHT
	4FT. LINEAR HANGING LIGHT
	600 x 600 MM LED LIGHT 36 WATT
	PROFILE LIGHT 5M
	HANGING LIGHT SYMBOL
	LED STRIP/COVE LIGHT

ELECTRICAL DRAWING			
DATE	DEALT	CHECKED	APPROVED
MAR 2025	SANDEEP	P. K.	D.S. MADAVU
DRAWING NO.:		REVISION	
KES-0983-0325-EP-04		Ro	
ELECTRICAL CONSULTANTS-		SCALE	
KRISHNA ENGINEERING SERVICES		SCALE	
BUILDING SERVICES AND ENGINEERING CONSULTANTS 8, CLUB DRIVE ROAD, JAY ROAD, CHITTOOR, MHRASHI NEW DELHI - 110003 (INDIA) MOBILE: 91 98680 3010 FAX: 98680 3010 Website: www.kesengg.com Email: kesengg@gmail.com kesengg@gmail.com aashish@kesengg.in			
			
<b>THE GRID</b> 			
architects and interior designers e-326 greater kailash-ii, new delhi - 110 048 ph : 011 - 2922 10 89 telefax : 011-47104393			
DRAWING RELEASED FOR:			
<input type="checkbox"/> APPROVAL <input type="checkbox"/> TENDER <input type="checkbox"/> FOR B.O.Q <input type="checkbox"/> CONSTRUCTION			
ARCHITECT SIGN.		CLIENT SIGN.	

PROPOSED OFFICE OF SBI CAPS AT 2ND FLOOR AT WORLD TRADE CENTRE, NAUROA, NGAARU, NEW DELHI

DWG. TITLE:

FIRE ALARM LAYOUT PLAN

-2ND FLOOR- R0

DATE:	REVISION

**CLIENT**

**SBI CAPS.**  
NEW DELHI

Creating Smartest Trading Solutions

---

---

NORTH

1. This drawing is a property of **THE GRID**.

2. Any modification/changes to the drawing can be done only after written permission from **THE GRID**.

3. This drawing must be read along with other architecture & services drawings.