


GENERAL NOTES

1. This drawing is a property of **THE GRID**.
2. Any modification/changes to the drawing can be done only after written permission from **THE GRID**.
3. This drawing must be read along with other architecture & services drawings.

NORTH

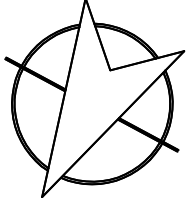

DATE: REVISION

CLIENT
**SBI CAPS,
NEW DELHI**

PROPOSED OFFICE OF SBI CAPS AT 2ND FLOOR, AT WORLD TRADE CENTRE, NAUROAD NGAR, NEW DELHI

DWG TITLE:
**POWER LAYOUT PLAN
LAYOUT -2ND FLOOR- RO**

SCALE:
N.T.S (written dimensions
to be followed)

DATE	DEALT	CHECKED	APPROVED	STATUS
MAR, 2025	SANDEEP	P.K	O.S. VADAV	PRELIMINARY DWG


ELECTRICAL CONSULTANTS:
KRISHNA ENGINEERING SERVICES
BUILDING SERVICES AND ENGINEERING CONSULTANTS
NEW DELHI - 110050 (INDIA)
PHONE # 011-2650 3018, FAX # 2650 3019
Website: www.kesengr.in, Email: kes@kesengr.in, kes.msp@kesengr.in

THE GRID

architects and interior designers
**e-325, greater kailash-II
new delhi -110 048
ph: 011-2922 1089
telefax : 011-47104393**

DRAWING RELEASED FOR:
☒ APPROVAL ☐ FOR B.O.Q
☒ TENDER ☐ CONSTRUCTION
ARCHITECT SIGN: CLIENT SIGN:

LEGEND	
	LOW HEIGHT PARTITION (UP TO 1200 MM HEIGHT)
	FULL HEIGHT PARTITION (UP TO FALSE CEILING)
	FULL HEIGHT PARTITION (UP TO FALSE CEILING)
	BRICK WALL

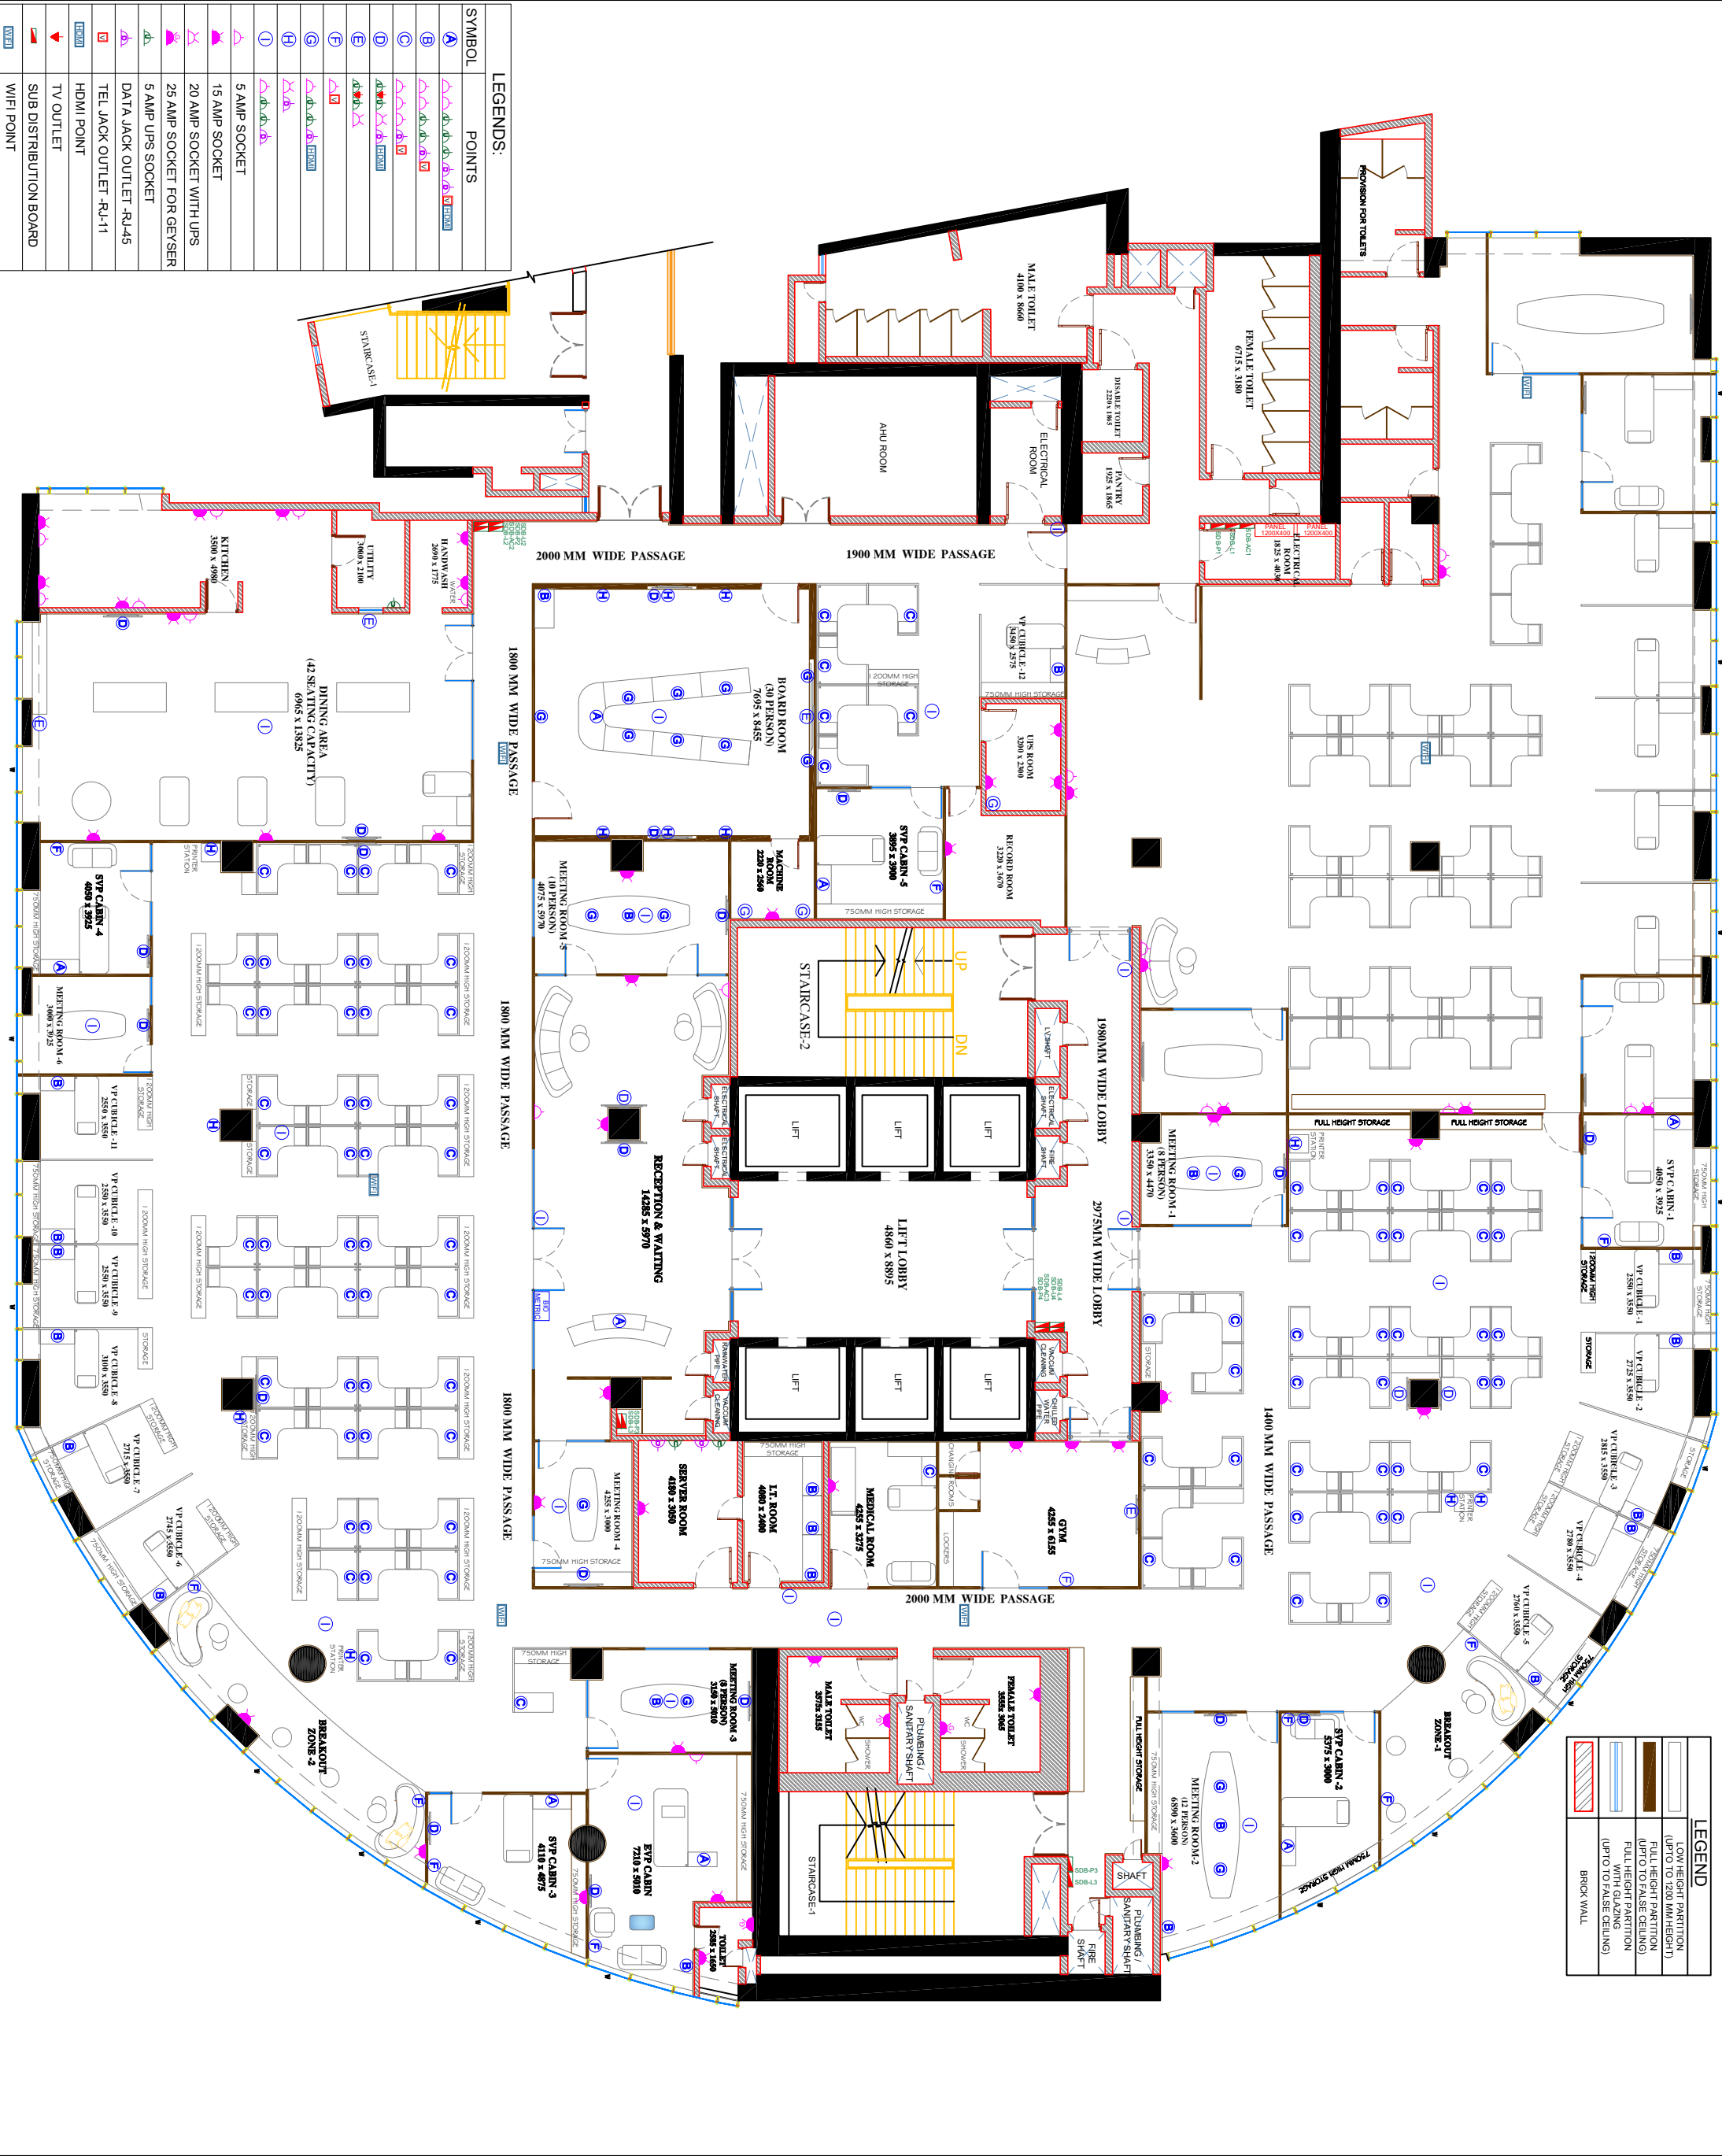

LEGENDS:	
SYMBOL	POINTS
	A
	B
	C
	D
	E
	F
	G
	H
	I
	J
	K
	L
	M
	N
	O
	P
	Q
	R
	S
	T
	U
	V
	W
	X
	Y
	Z
	AA
	AB
	AC
	AD
	AE
	AF
	AG
	AH
	AI
	AJ
	AK
	AL
	AM
	AN
	AO
	AP
	AQ
	AR
	AS
	AT
	AU
	AV
	AW
	AX
	AY
	AZ
	BA
	BB
	BC
	BD
	BE
	BF
	BG
	BH
	BI
	BJ
	BK
	BL
	BM
	BN
	BO
	BP
	BQ
	BR
	BS
	BT
	BU
	BV
	BW
	BX
	BY
	BZ
	CA
	CB
	CC
	CD
	CE
	CF
	CG
	CH
	CI
	CJ
	CK
	CL
	CM
	CN
	CO
	CP
	CQ
	CR
	CS
	CT
	CU
	CV
	CW
	CX
	CY
	CZ
	DA
	DB
	DC
	DD
	DE
	DF
	DG
	DH
	DI
	DJ
	DK
	DL
	DM
	DN
	DO
	DP
	DQ
	DR
	DS
	DT
	DU
	DV
	DW
	DX
	DY
	DZ
	EA
	EB
	EC
	ED
	EE
	EF
	EG
	EH
	EI
	EJ
	EK
	EL
	EM
	EN
	EO
	EP
	EQ
	ER
	ES
	ET
	EU
	EV
	EW
	EX
	EY
	EZ
	FA
	FB
	FC
	FD
	FE
	FF
	FG
	FH
	FI
	FJ
	FK
	FL
	FM
	FN
	FO
	FP
	FQ
	FR
	FS
	FT
	FU
	FV
	FW
	FX
	FY
	FZ
	GA
	GB
	GC
	GD
	GE
	GF
	GG
	GH
	GI
	GJ
	GK
	GL
	GM
	GN
	GO
	GP
	GQ
	GR
	GS
	GT
	GU
	GV
	GW
	GX
	GY
	GZ
	HA
	HB
	HC
	HD
	HE
	HF
	HG
	HH
	HI
	HJ
	HK
	HL
	HM
	HN
	HO
	HP
	HQ
	HR
	HS
	HT
	HU
	HV
	HW
	HX
	HY
	HZ
	IA
	IB
	IC
	ID
	IE
	IF
	IG
	IH
	II
	IJ
	IK
	IL
	IM
	IN
	IO
	IP
	IQ
	IR
	IS
	IT
	IU
	IV
	IW
	IX
	IY
	IZ
	JA
	JB
	JC
	JD
	JE
	JF
	JG
	JH
	JI
	JJ
	JK
	JL
	JM
	JN
	JO
	JP
	JQ
	JR
	JS
	JT
	JU
	JV
	JW
	JX
	JY
	JZ
	KA
	KB
	KC
	KD
	KE
	KF
	KG
	KH
	KI
	KJ
	KK
	KL
	KM
	KN
	KO
	KP
	KQ
	KR
	KS
	KT
	KU
	KV
	KW
	KX
	KY
	KZ
	LA
	LB
	LC
	LD
	LE
	LF
	LG
	LH
	LI
	LJ
	LK
	LL
	LM
	LN
	LO
	LP
	LQ
	LR
	LS
	LT
	LU
	LV
	LW
	LX
	LY
	LZ
	MA
	MB
	MC
	MD
	ME
	MF
	MG
	MH
	MI
	MJ
	MK
	ML
	MM
	MN
	MO
	MP
	MQ
	MR
	MS
	MT
	MU
	MV
	MW
	MX
	MY
	MZ
	NA
	NB
	NC
	ND
	NE
	NF
	NG
	NH
	NI
	NJ
	NK
	NL
	NM
	NN
	NO
	NP
	NQ
	NR
	NS
	NT
	NU
	NV
	NW
	NX
	NY
	NZ
	OA
	OB
	OC
	OD
	OE
	OF
	OG
	OH
	OI
	OJ
	OK
	OL
	OM
	ON
	OO
	OP
	OQ
	OR
	OS
	OT
	OU
	OV
	OW
	OX
	OY
	OZ
	PA
	PB
	PC
	PD
	PE
	PF
	PG
	PH
	PI
	PJ
	PK
	PL
	PM
	PN
	PO
	PP
	PQ
	PR
	PS
	PT
	PU
	PV
	PW
	PX
	PY
	PZ
	QA
	QB
	QC
	QD
	QE
	QF
	QG
	QH
	QI
	QJ
	QK
	QL
	QM
	QN
	QO
	QP
	QQ
	QR
	QS
	QT
	QU
	QV
	QW
	QX
	QY
	QZ
	RA
	RB
	RC
	RD
	RE
	RF
	RG
	RH
	RI
	RJ
	RK
	RL
	RM
	RN
	RO
	RP
	RQ
	RR
	RS
	RT
	RU
	RV
	RW
	RX
	RY
	RZ
	SA
	SB
	SC
	SD
	SE
	SF
	SG
	SH
	SI
	SJ
	SK
	SL
	SM
	SN
	SO
	SP
	SQ
	SR
	SS
	ST
	SU
	SV
	SW
	SX
	SY
	SZ
	TA
	TB
	TC
	TD